

*DRAWINGS FOR REFERENCE ONLY. VERIFY ALL DIMENSIONS ON SITE.

SUZIE ATKIN
INTENTIONAL DESIGN

SUZIE@SUZIEATKIN.COM
(503) 341-7613

Drawn:
 Revised: REV2
 Revised: REV3
 Revised: REV4
 Revised: REV5
 Revised: REV6
 Revised: REV7
 Revised: REV8

CONSTRUCTION PROJECT FOR:

PAGE
1 of 20
 MASTER BATH

ELECTRICAL LEGEND

All new and reworked outlets in kitchen and bathrooms to be on GFCI

All new and reworked outlets in bedrooms to be on AFCI

Single Pole Switch	Ⓢ
3-way Switch	Ⓢ
4-way Switch	Ⓢ
Switch - Dimmer	Ⓢ
Switch - Timer	Ⓢ

110v Duplex Outlet	Ⓢ
110v Fourplex Outlet	Ⓢ
110v Floor Outlet	Ⓢ
220v Outlet	Ⓢ
Appliance Circuit	Ⓢ

Ceiling Light Fixture	Ⓢ
Wall Light Fixture	Ⓢ
Pendant Light	Ⓢ
Light Head	Ⓢ
Recessed Light Fixture	Ⓢ
Under-cabinet Light	Ⓢ
Puck Light	Ⓢ

Garbage Disposal	Ⓢ
Exhaust Fan only	Ⓢ
Exhaust Fan/Light	Ⓢ
Telephone	Ⓢ
Cable TV	Ⓢ
Smoke Detector	Ⓢ
CO Detector	Ⓢ

New	N
Existing	E
Timer	T

WIRE FOR HEATED FLOOR IN MAIN BATH & TOILET ROOM (NOT SHOWER) & LOCATE THERMOSTAT


WIRE FOR LIGHTED MIRROR

(2) OUTLETS (1 IN BASE CAB)

MASTER BATH

CH: SLOPED w/ ROOF

54 1/4" H WALL w/ SHOWER NICHE & GLASS PANEL

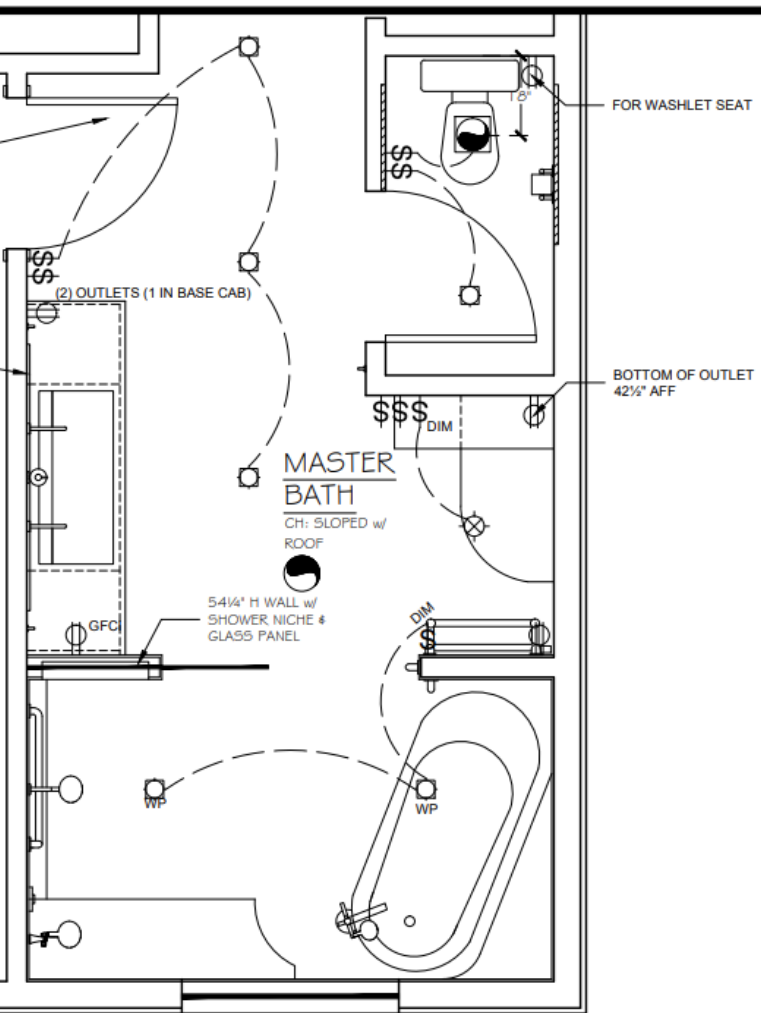


SUZIE ATKIN
INTENTIONAL DESIGN

SUZIE@SUZIEATKIN.COM
(503) 341-7613


Drawn:
Revised: REV2
Revised: REV3
Revised: REV4
Revised: REV5
Revised: REV6
Revised: REV7
Revised: REV8

CONSTRUCTION PROJECT FOR:

*DRAWINGS FOR REFERENCE ONLY. VERIFY ALL DIMENSIONS ON SITE.

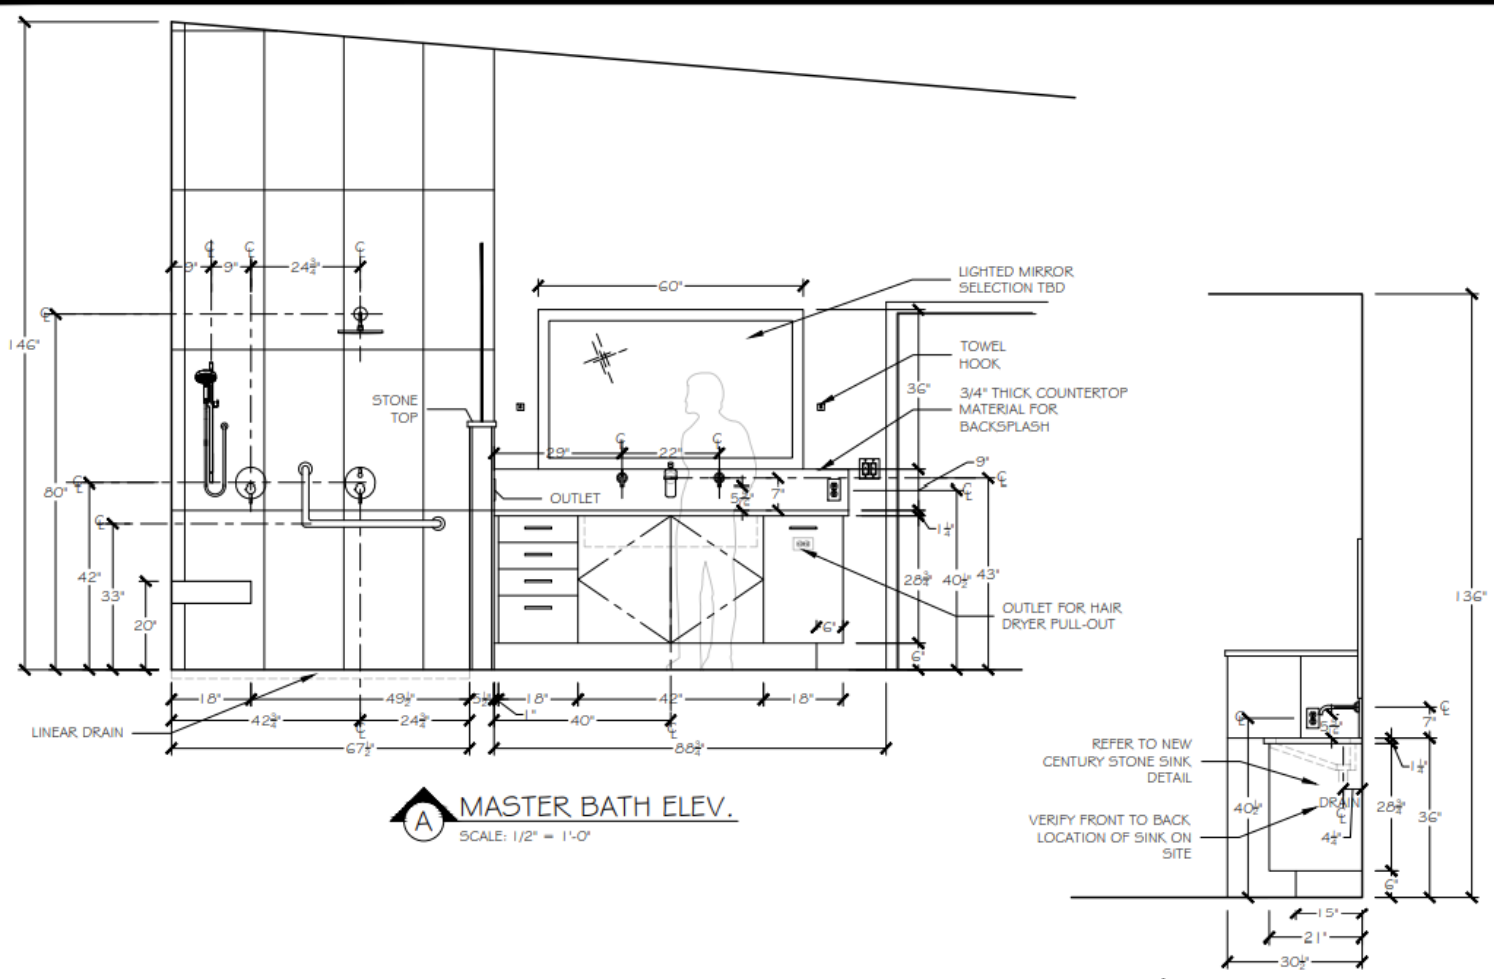

A MASTER BATH ELEV.
SCALE: 1/2" = 1'-0"

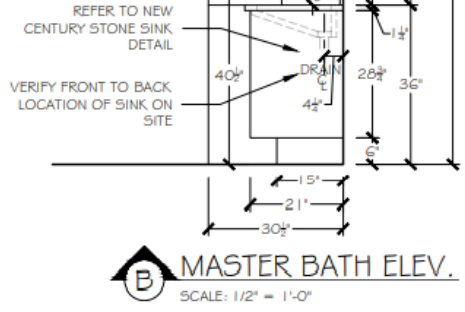

B MASTER BATH ELEV.
SCALE: 1/2" = 1'-0"


*DRAWINGS FOR REFERENCE ONLY.
VERIFY ALL DIMENSIONS ON SITE.

SUZIE ATKIN
INTENTIONAL DESIGN

SUZIE@SUZIEATKIN.COM
(503) 341-7613

Drawn:
Revised: REV2
Revised: REV3
Revised: REV4
Revised: REV5
Revised: REV6
Revised: REV7
Revised: REV8

CONSTRUCTION PROJECT FOR:

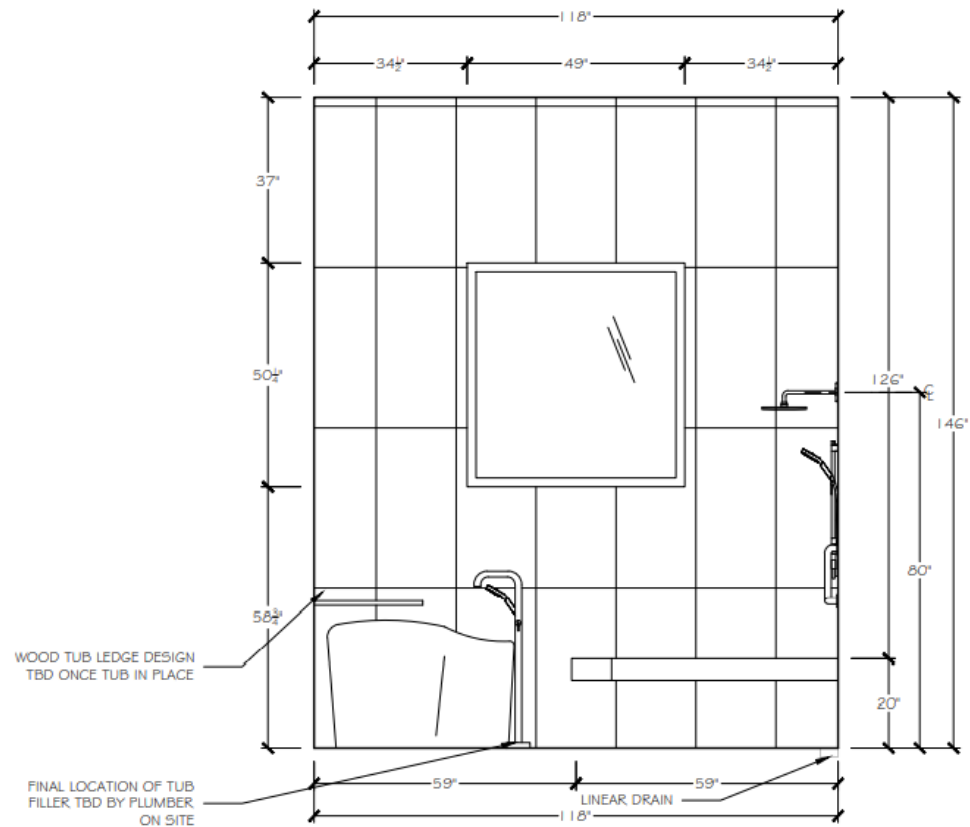

WOOD TUB LEDGE DESIGN
TBD ONCE TUB IN PLACE

FINAL LOCATION OF TUB
FILLER TBD BY PLUMBER
ON SITE

MASTER BATH ELEV.
SCALE: 1/2" = 1'-0"



SUZIE ATKIN
INTENTIONAL DESIGN

SUZIE@SUZIEATKIN.COM
(503) 341-7613

Drawn:
Revised:
Revised: G/10/21
Revised: RD/3
Revised: RD/4
Revised: RD/5
Revised: RD/6
Revised: RD/7
Revised: RD/8

CONSTRUCTION PROJECT FOR:

PAGE
4 of 20

MASTER BATH

*DRAWINGS FOR REFERENCE ONLY.
VERIFY ALL DIMENSIONS ON SITE.